


LOCATION MAP (SCALE 1:1000)

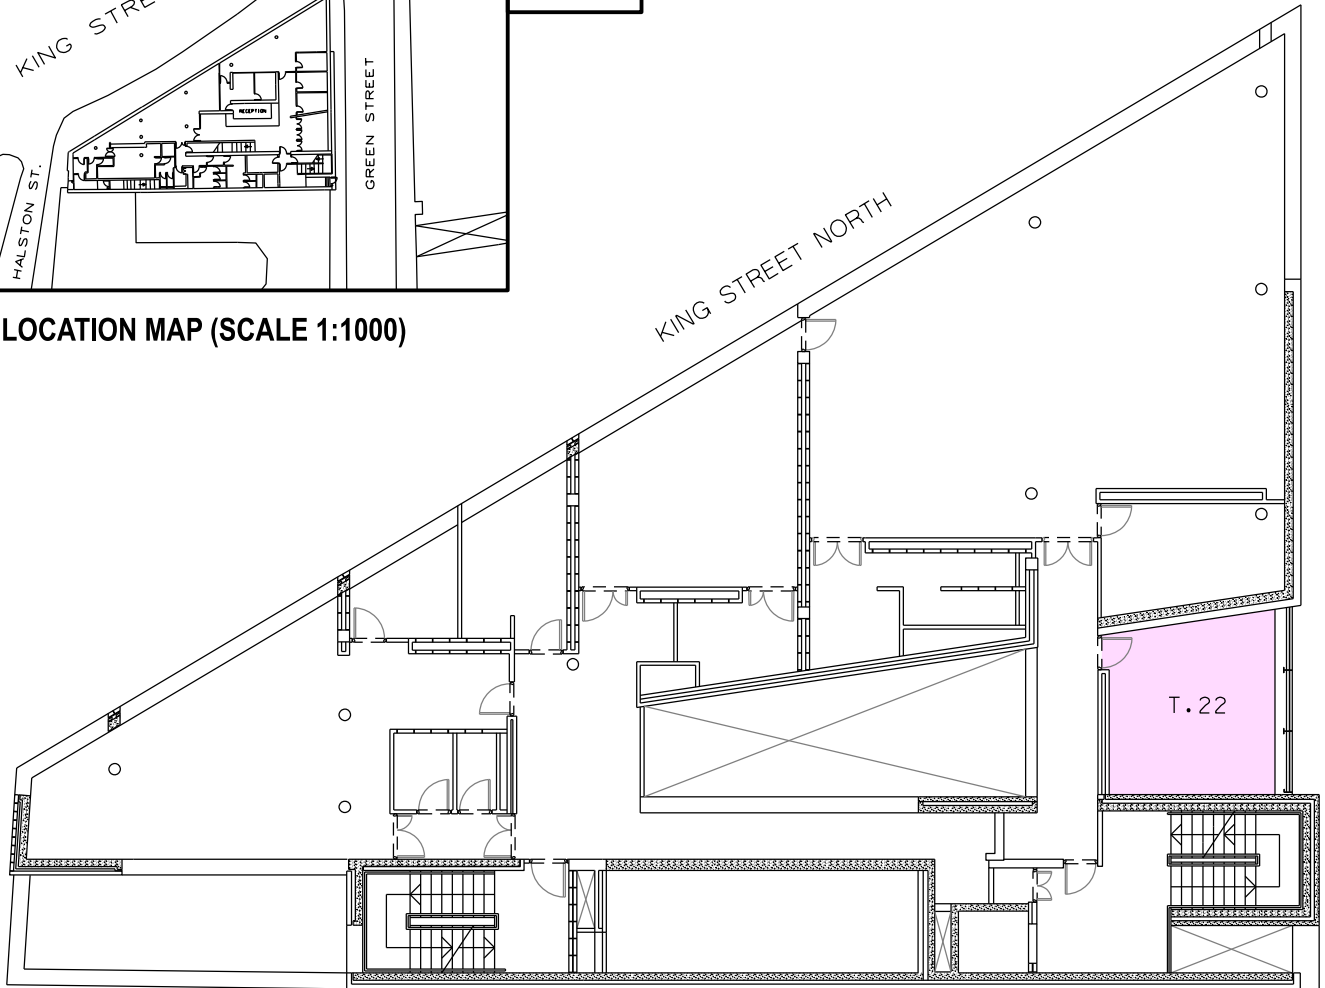

THIRD FLOOR PLAN (SCALE 1:200)

HALSTON STREET / NORTH KING STREET / GREEN STREET - MACRO BUILDING  
 Room T.22 (AREA: 20.3 sq m)  
 Dublin City Council to Safetynet Primary Care CLG  
 DISPOSAL OF LICENCE



Comhairle Cathrach  
 Bhaile Átha Cliath  
 Dublin City Council

An Roinn Comhshaoil agus Iompair  
 Rannán Suirbhéireachta agus Léarscáilithe  
 Environment and Transportation Department  
 Survey and Mapping Division

|                  |                               |
|------------------|-------------------------------|
| <b>O.S REF</b>   | <b>SCALE</b>                  |
| 3263-04, 3263-05 | 1:1000 / 1:200                |
| <b>DATE</b>      | <b>SURVEYED / PRODUCED BY</b> |
| 26.04.2022       | TJC                           |

|                 |                               |            |
|-----------------|-------------------------------|------------|
| <b>INDEX No</b> | <b>DWG No</b>                 | <b>REV</b> |
| <b>FILE NO</b>  | F:\SM-2022-0196 - 001 - A.dgn |            |

THIS MAP IS CERTIFIED TO BE COMPUTER GENERATED BY  
 DUBLIN CITY COUNCIL FROM ORDNANCE SURVEY DIGITAL MAPBASE  
 SURVEY, MAPPING AND RELATED RESEARCH APPROVED

**Dr JOHN W. FLANAGAN**  
 CEng FIEI FICE  
 CITY ENGINEER

APPROVED \_\_\_\_\_  
**THOMAS CURRAN**  
 ACTING MANAGER LAND SURVEYING & MAPPING  
 DUBLIN CITY COUNCIL

**INDEX No.**  
**SM-2022-0196**