
 


LOCATION MAP SCALE 1:1000

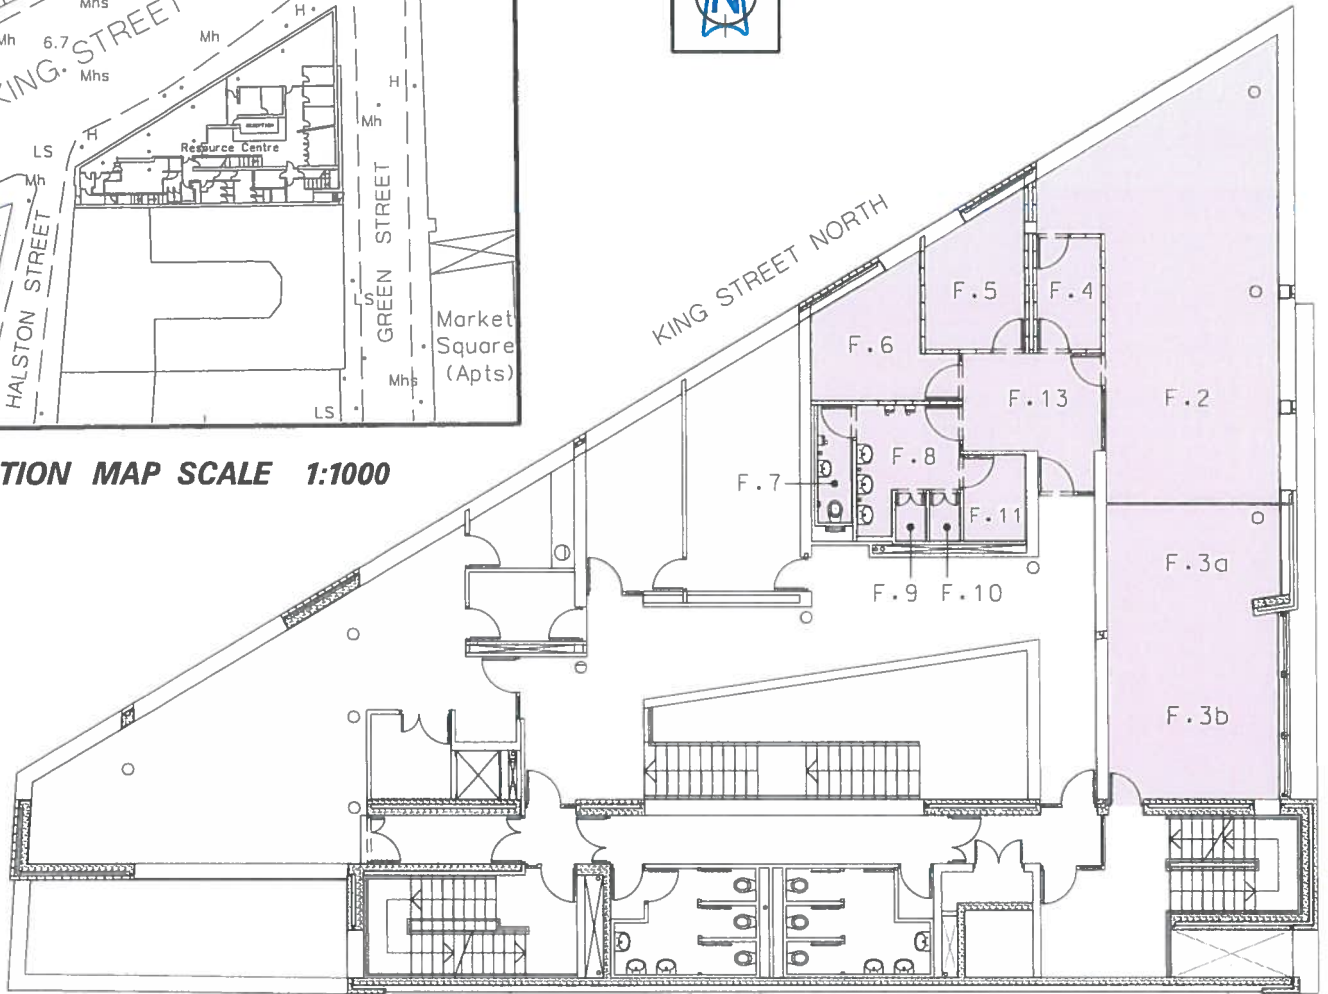

FIRST FLOOR PLAN (SCALE 1:200)

HALSTON STREET /NORTH KING STREET /GREEN STREET - MACRO BUILDING
Rooms F.2 - F.10, F.11, F.13 (AREA: 142 sq m)
Dublin City Council to Pitter Patter Creche
DISPOSAL OF LICENCE



DUBLIN CITY COUNCIL

Comhairle Cathrach Bhaile Átha Cliath
ENVIRONMENT AND ENGINEERING DEPARTMENT
An Roinn Comhshaoil agus Innealtóireachta
SURVEY AND MAPPING SERVICES DIVISION
Rannán Seirbhísi Suirbhéireachta agus Léarscailithe

O.S REF	SCALE
3263-04, 3263-05	1:1000 / 1:200

DATE	SURVEYED / PRODUCED BY
15.02.2013	TJC

INDEX No	FOLDER No	CODE	DWG No	REV
FILE NO	SM-2010-0367-0204- C3 - 003 - A.dgn			

FOR PROPERTY REGISTRATION AUTHORITY PURPOSES ONLY
THIS MAP IS CERTIFIED TO BE COMPUTER GENERATED BY DUBLIN CITY COUNCIL FROM ORDNANCE SURVEY DIGITAL MAPBASE

MICHAEL PHILLIPS
CITY ENGINEER

SIGNED _____
PATRICK SHINE
MANAGER LAND SURVEYING & MAPPING
DUBLIN CITY COUNCIL

INDEX No.

SM-2010-0367-003